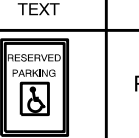
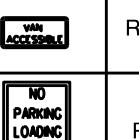
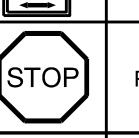
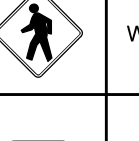
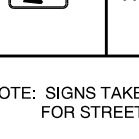

 
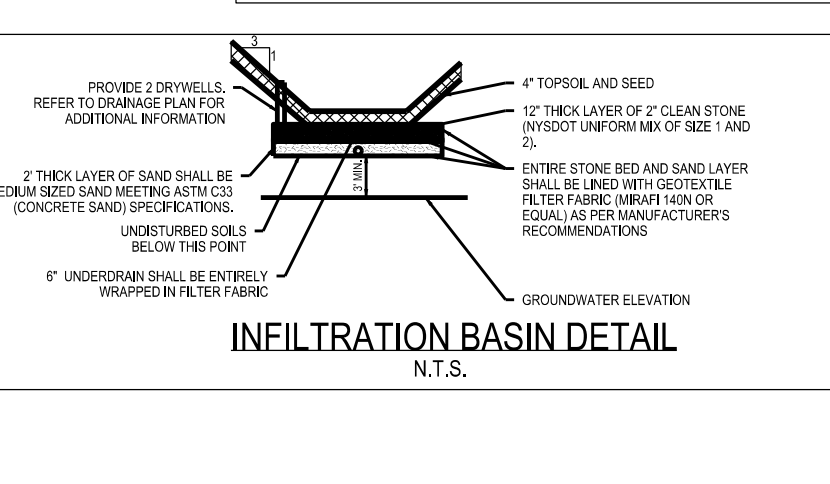
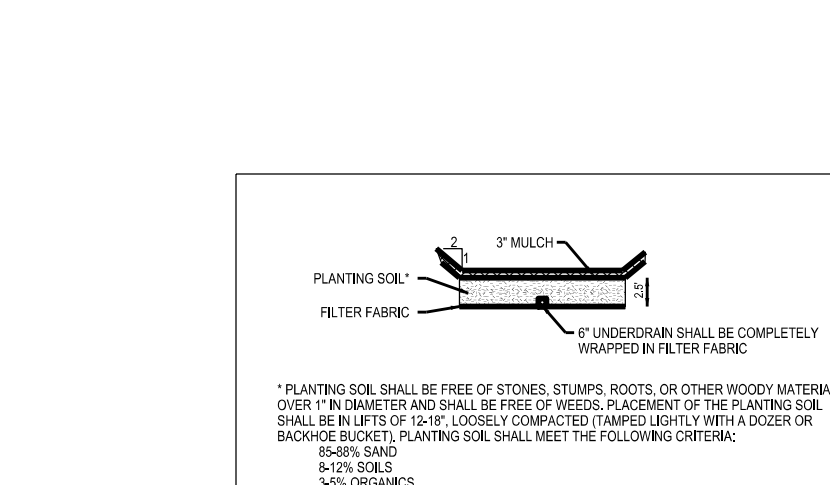
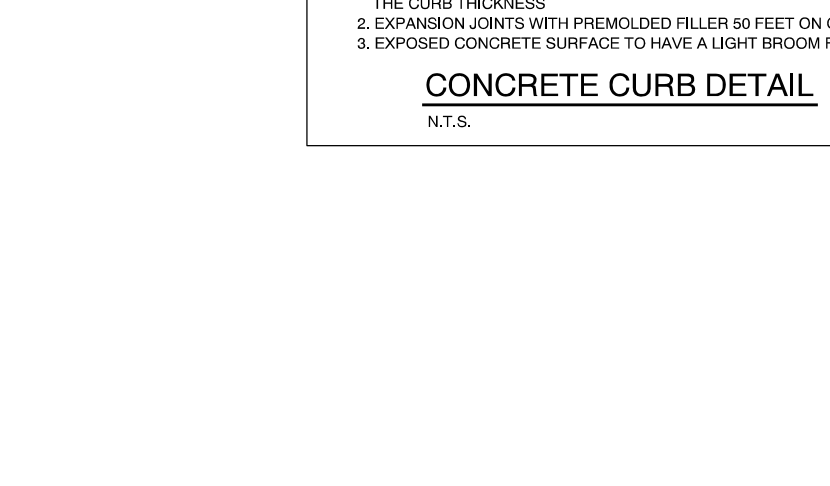
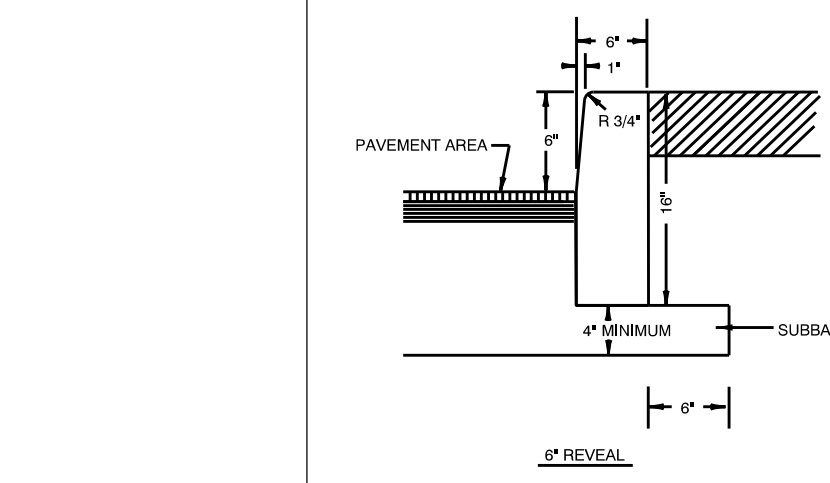
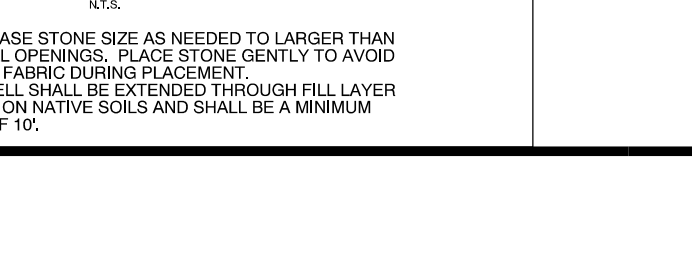
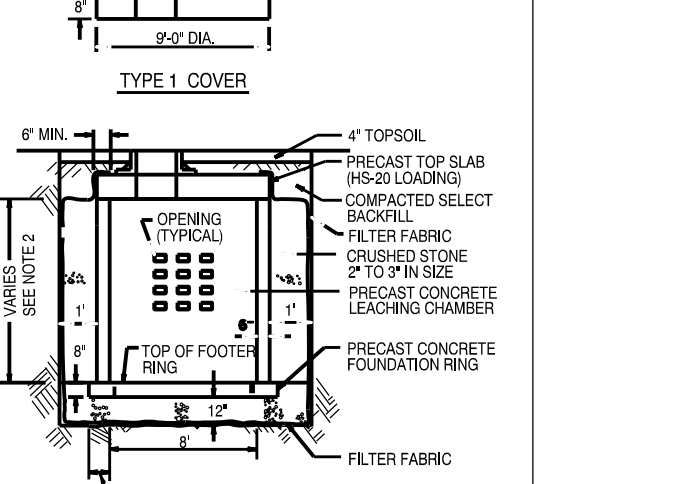
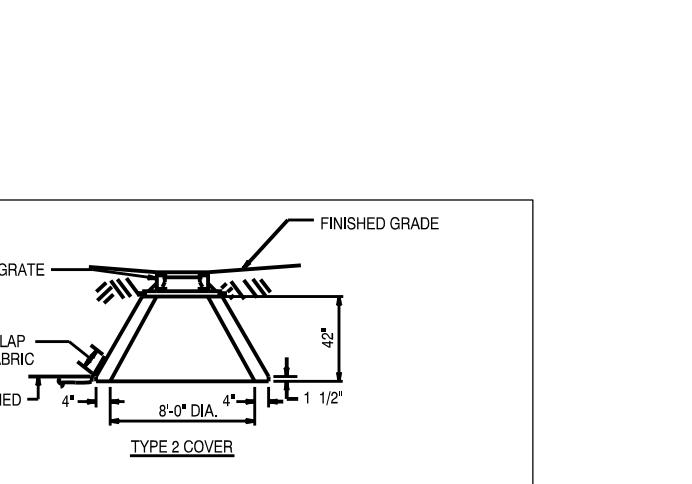
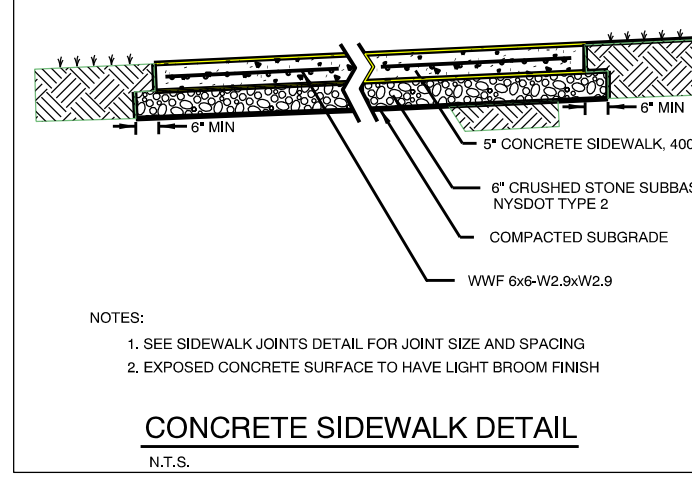
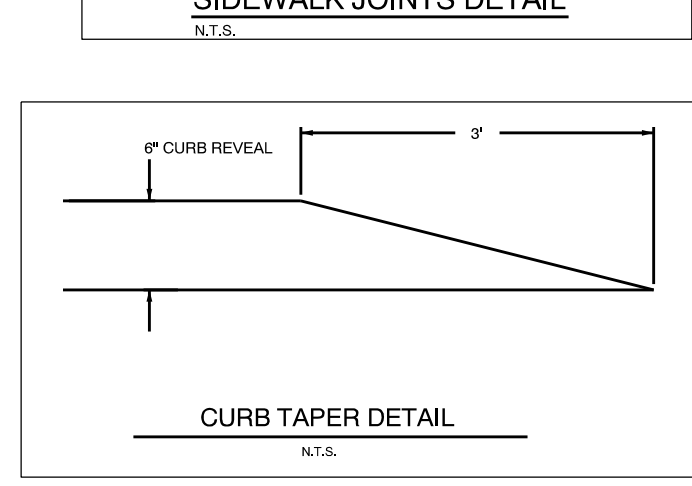
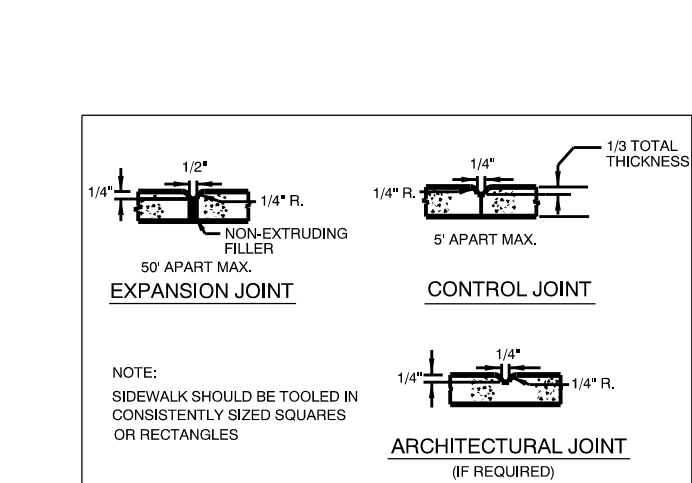
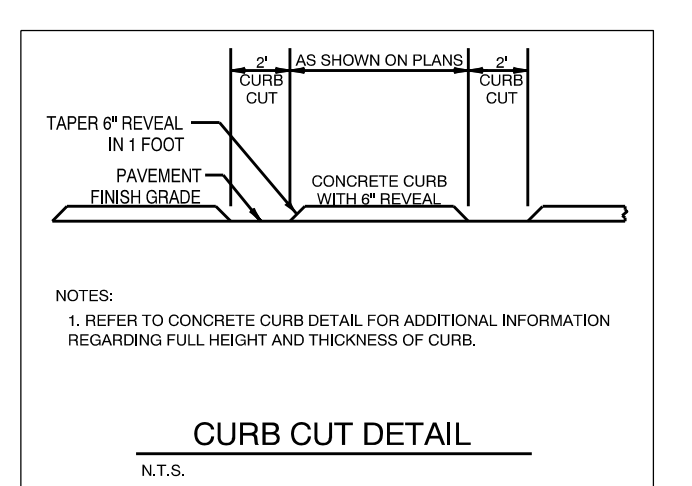
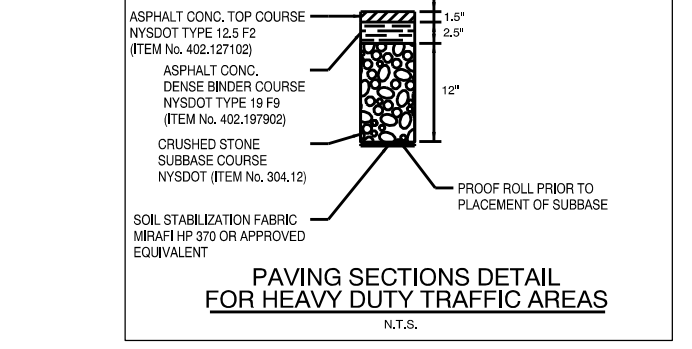
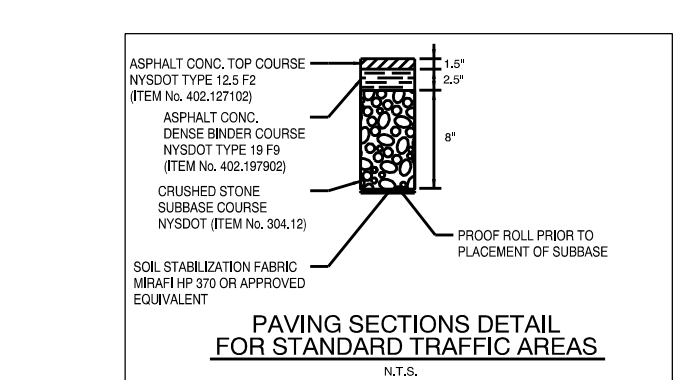
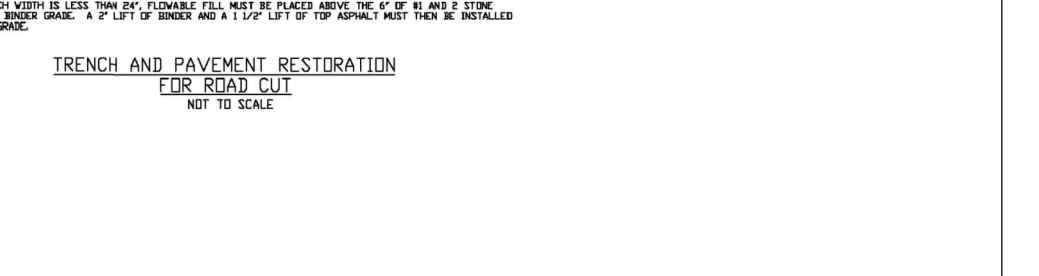
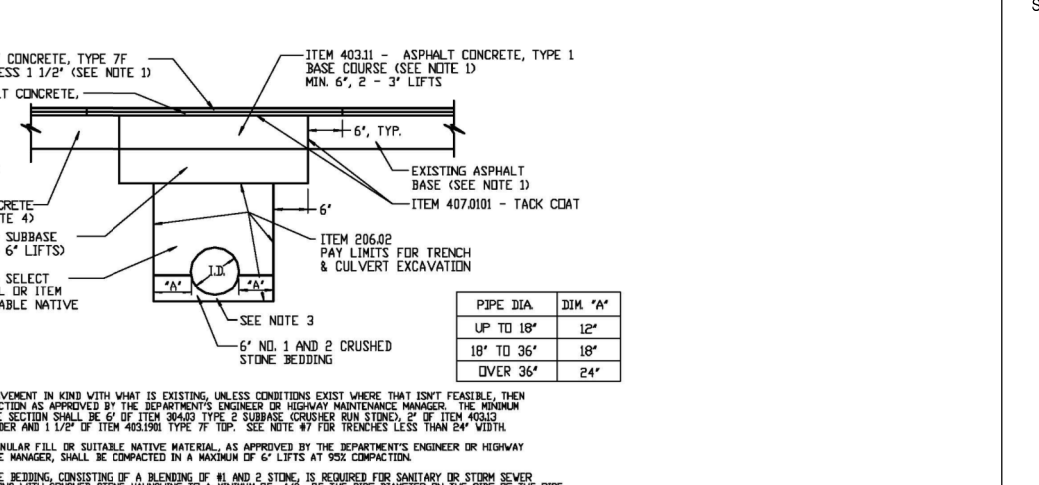
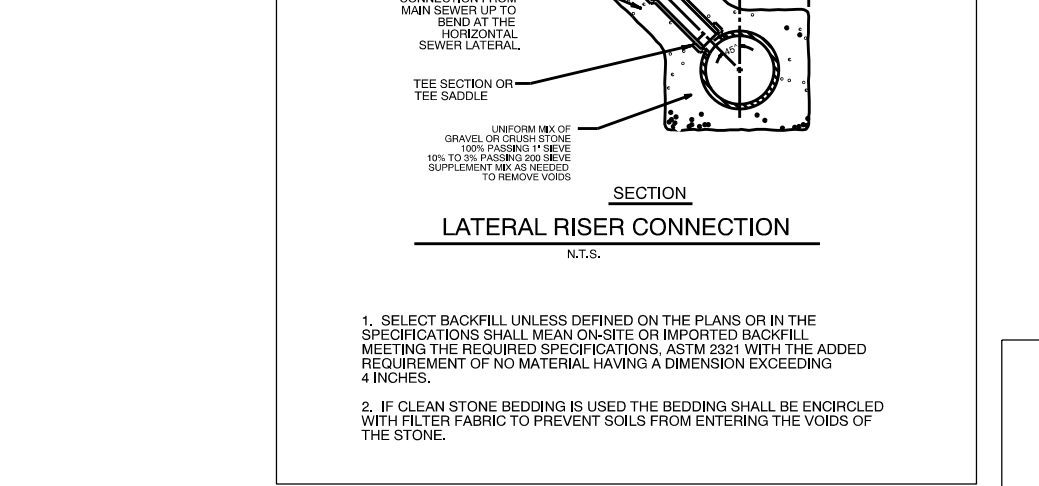
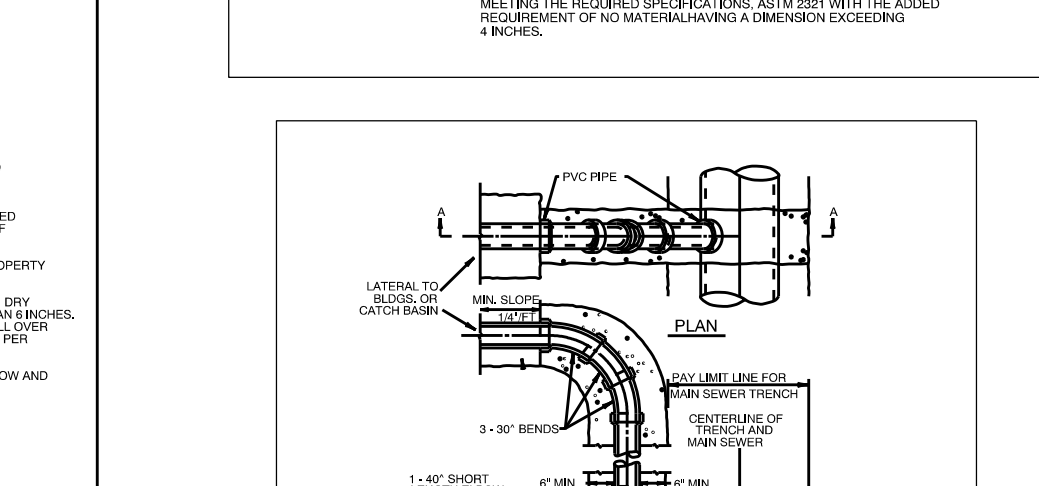
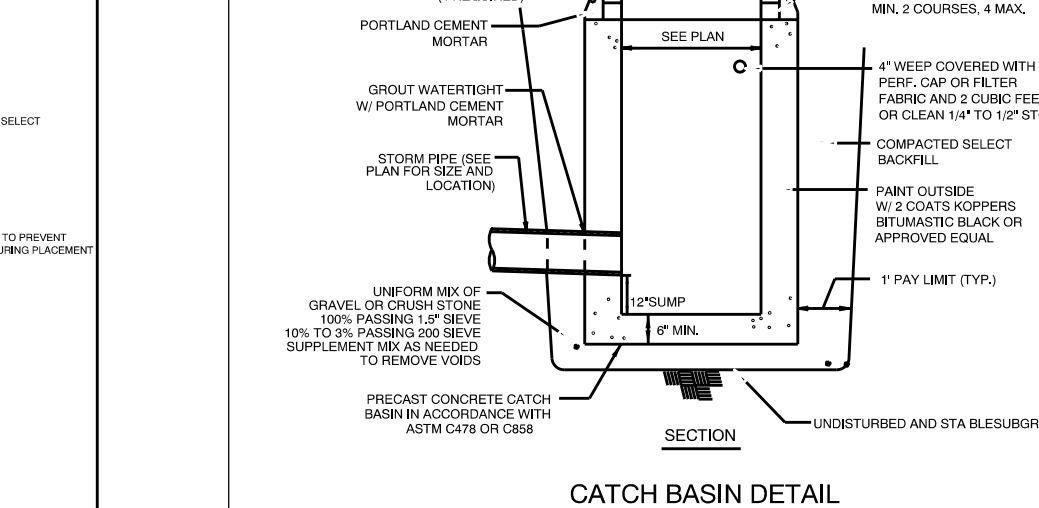
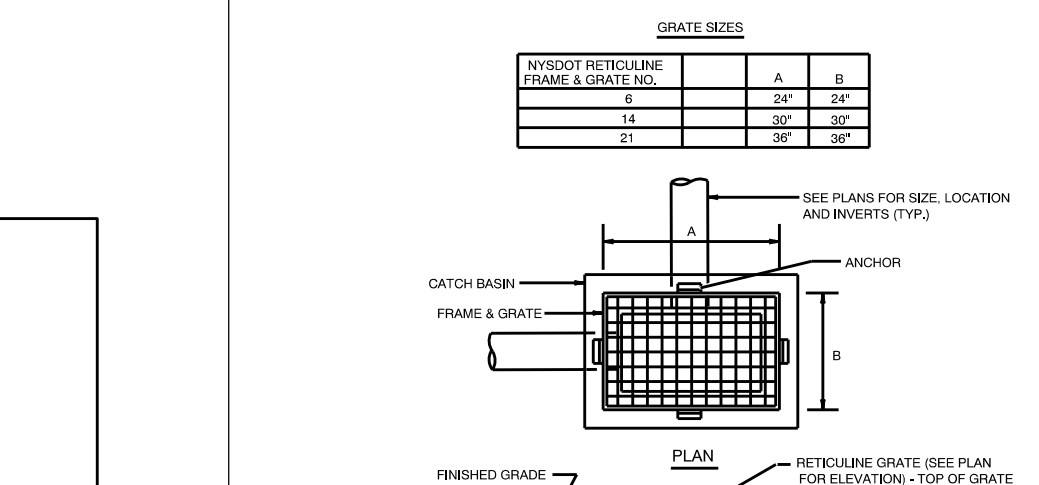
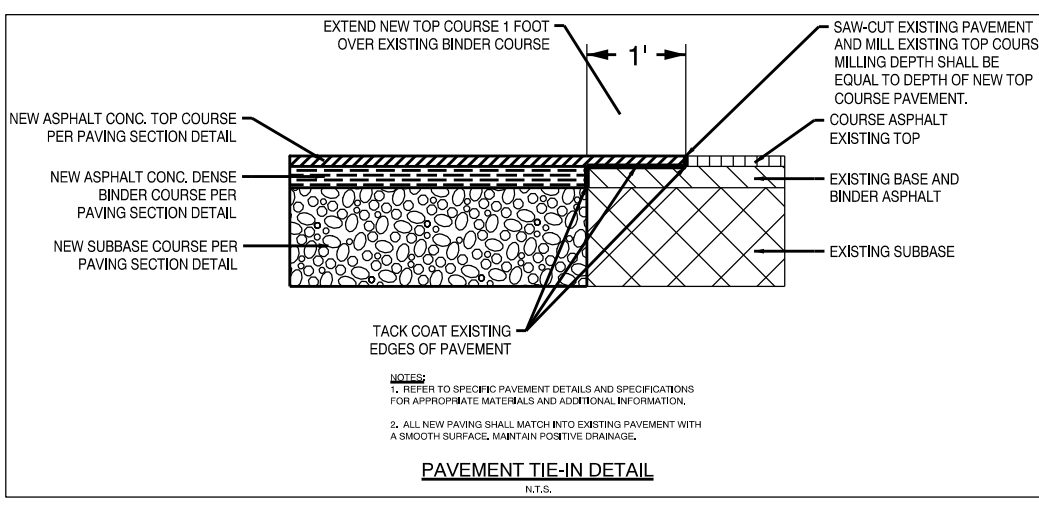
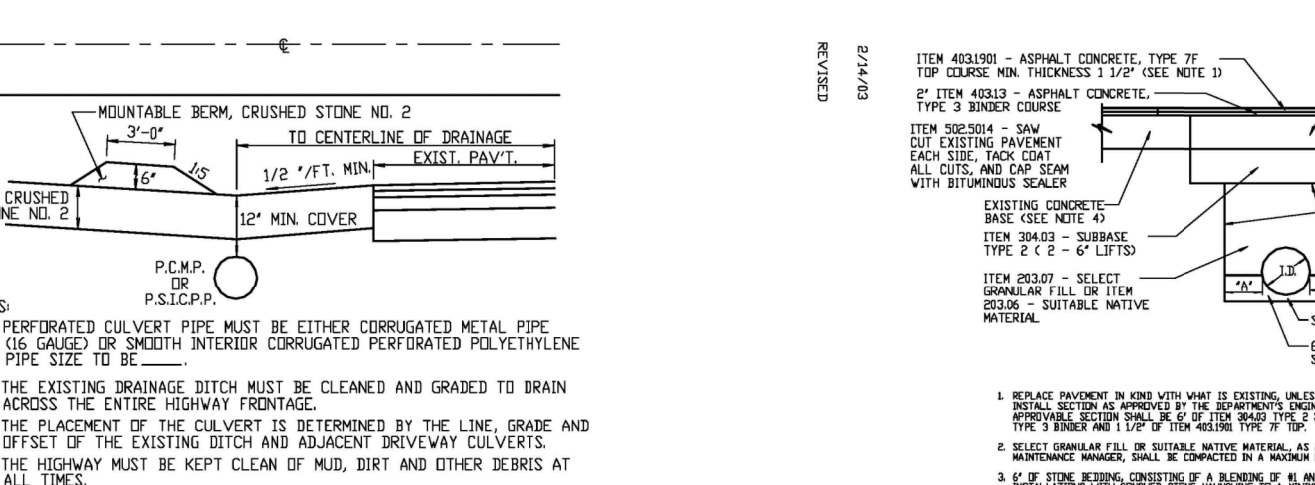
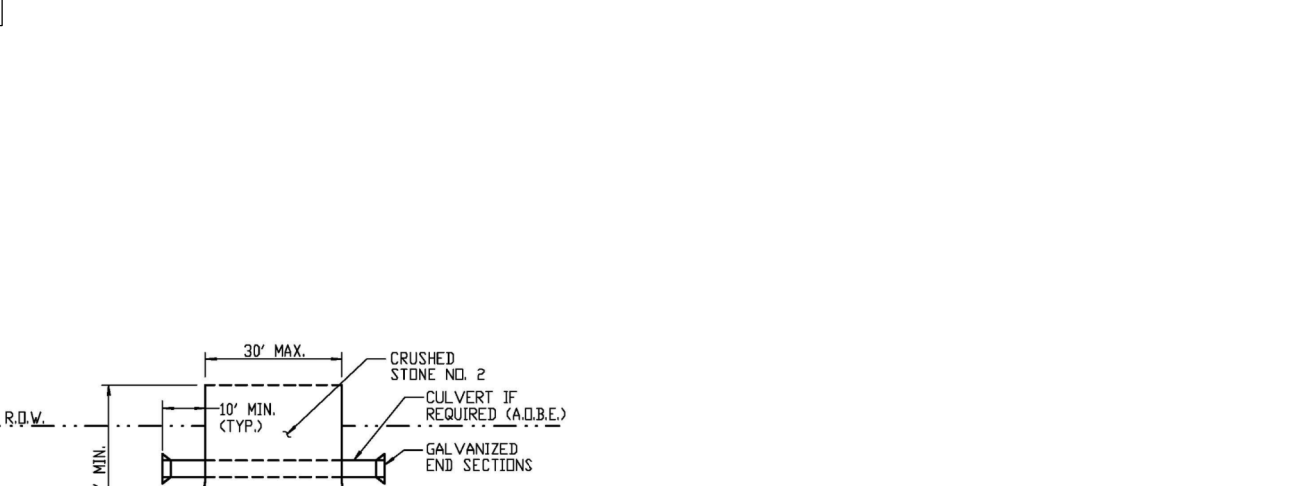
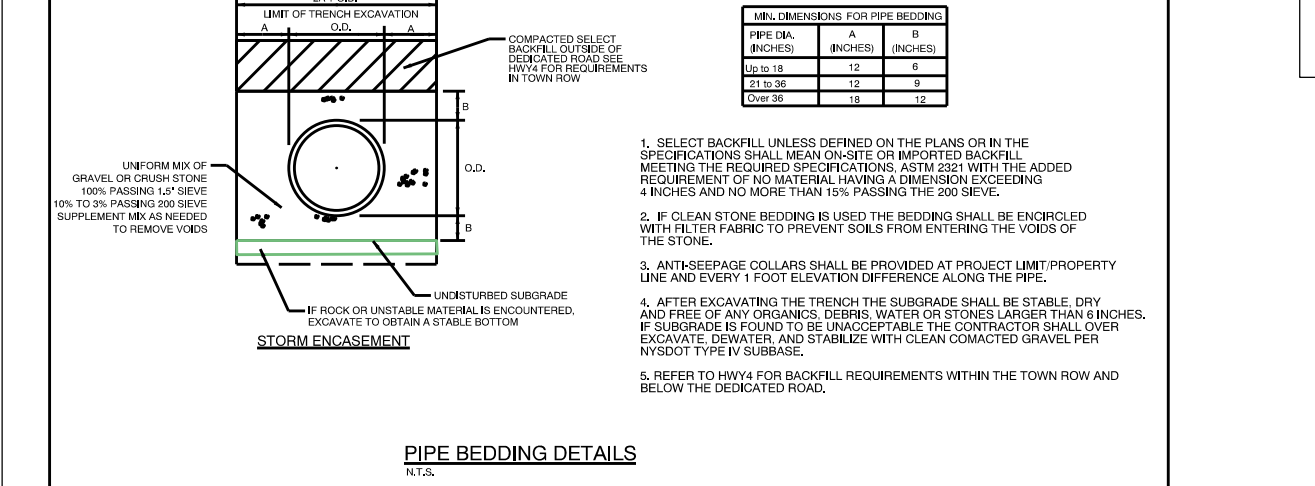
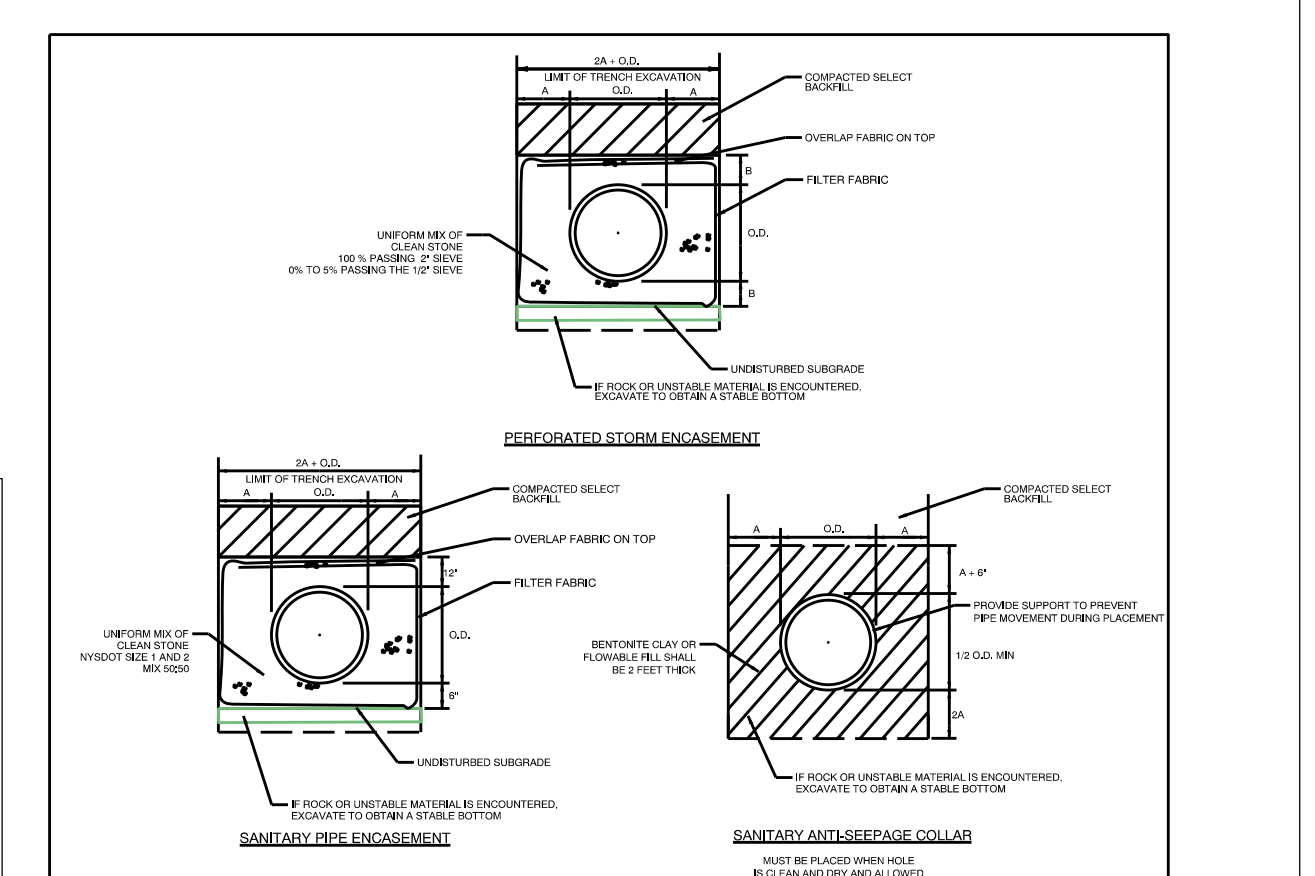
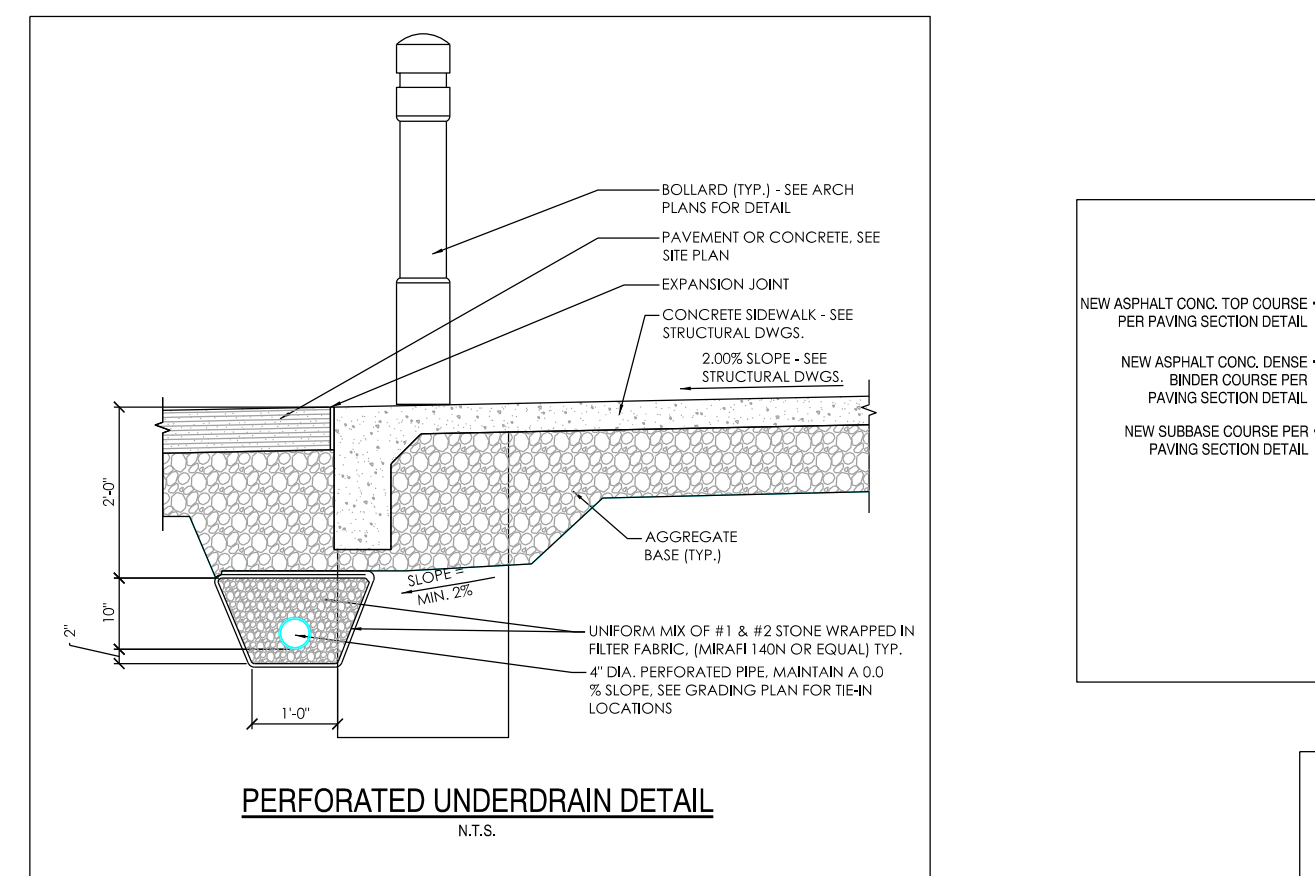
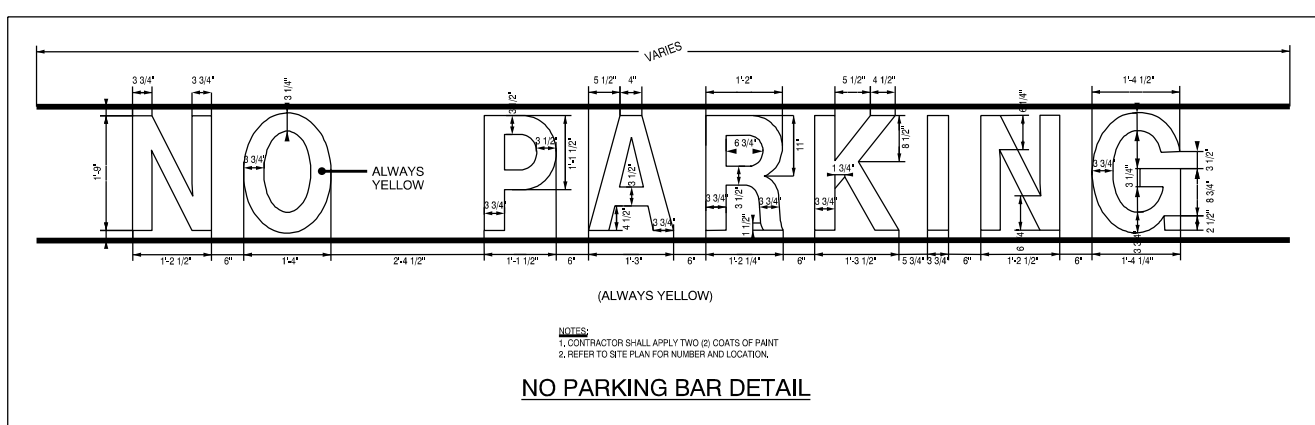
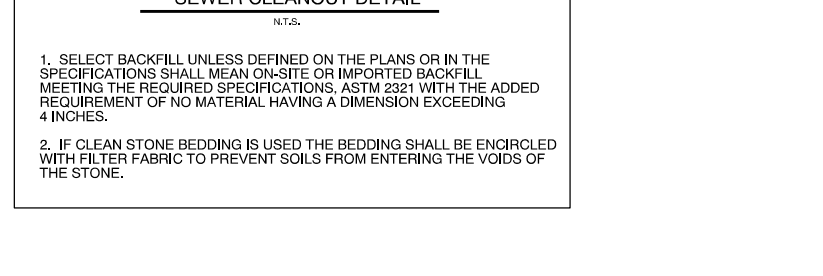
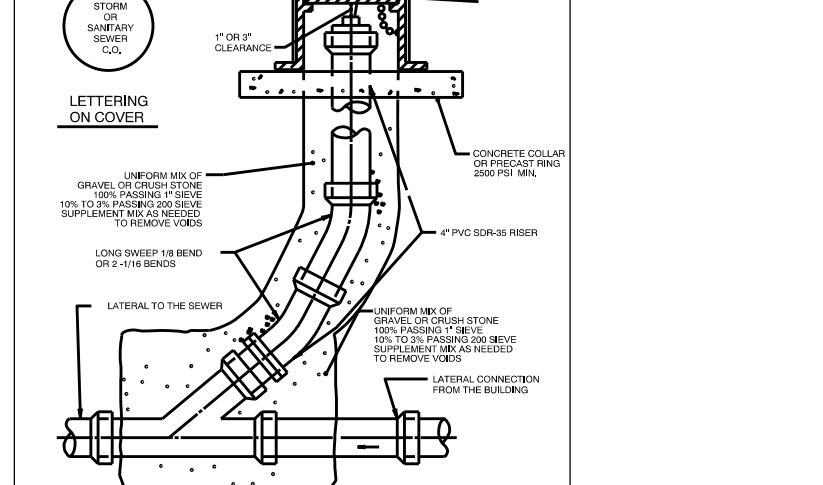
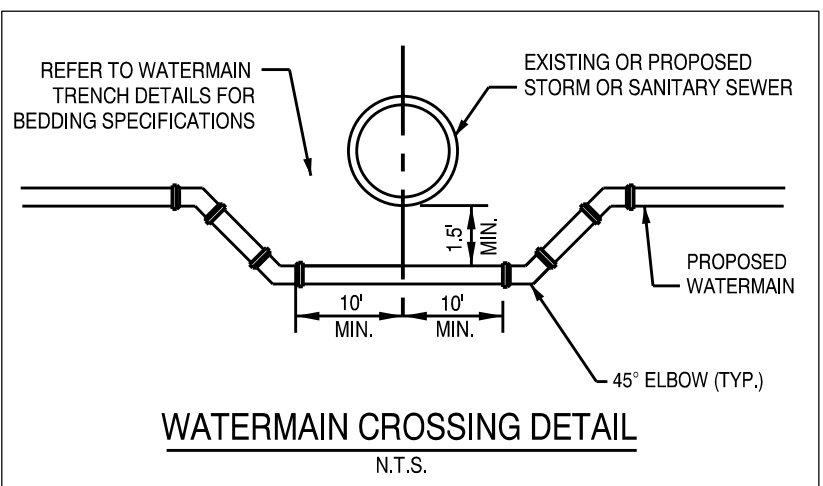
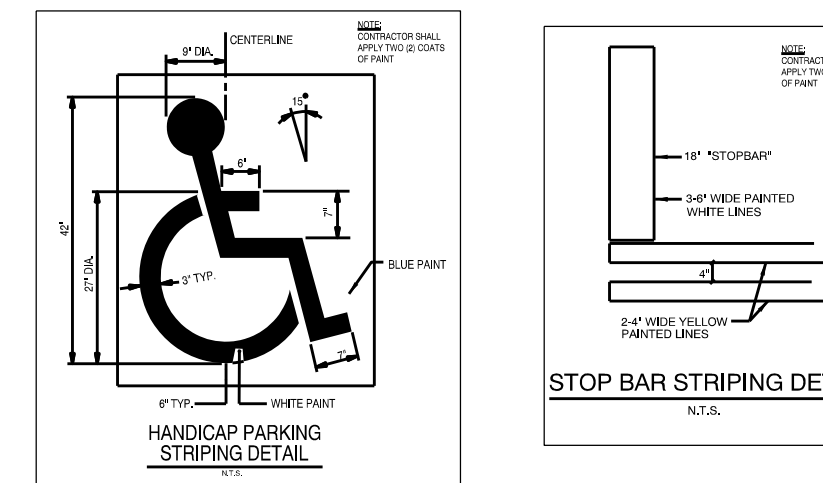
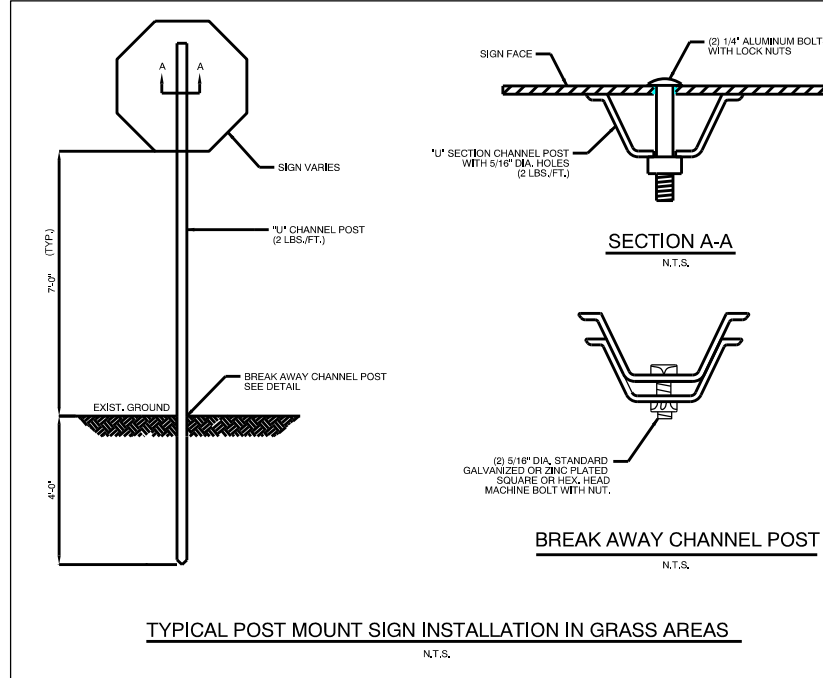


SIGN SCHEDULE					
TEXT	KEY	DESCRIPTION	TYPE OR MOUNT	HEIGHT	QUANTITY
	R 7-8	12"x18"	BUILDING MOUNTED	7'-0"	4
	R 7-8P	16"x16" GREEN LEGEND ON WHITE BACKGROUND	BUILDING MOUNTED	7'-0"	1
	R 7-6	12"x18"	BUILDING MOUNTED	7'-0"	3
	R 1-1	30" x 30" OCCASIONAL WHITE ON RED	POST MOUNTED	7'-0"	3
	W11-2	30" x 30" BLACK LEGEND WITH FLUORESCENT YELLOW-GREEN BACKGROUND	POST MOUNTED WITH BOLLARD FOR HARD INDICATED ON SITE PLAN	7'-0"	2
	W16-7P	24" x 12" BLACK LEGEND WITH FLUORESCENT YELLOW-GREEN BACKGROUND	POST MOUNTED WITH BOLLARD FOR HARD INDICATED ON SITE PLAN	7'-0"	2

NOTE: SIGNS TAKEN FROM NATIONAL MANUAL ON UNIFORM TRAFFIC CONTROL DEVICES FOR STREETS AND HIGHWAYS - 2003 EDITION.



Issued:	Date:
A	
B	
C	
D	
E	
F	
G	
H	
I	
J	
Revisions:	Date:
1	
2	
3	
4	
5	
6	
7	
8	
9	
10	
11	

Seal	Seal
PROJECT MANAGER	DATE
PROJECT ENGINEER / ARCHITECT	DATE
PROJECT DESIGNER	DATE

Seal	Seal
PROJECT MANAGER	DATE
PROJECT ENGINEER / ARCHITECT	DATE
PROJECT DESIGNER	DATE

Copyright © 2014
APD Engineering & Architecture
Drawing Alteration
It is a violation of law for any person, unless acting under the direction of a Licensed Architect, Professional Engineer, Landscape Architect, or Land Surveyor to alter any item on this document in any way.
Any licensee who alters this document is required by law to affix his or her seal and to add the notation "Altered By" followed by his or her signature and the specific description of the alteration or revision.

DO NOT SCALE PLANS
Copying, Printing, Software and other processes required to produce these prints can stretch or shrink the actual paper or layout. Therefore, scaling of this drawing may be inaccurate. Contact APD Engineering with any need for additional dimensions or clarifications.

APD Engineering & Architecture
615 Fishers Run
Victor, NY 14564
585.742.2222
585.924.4914 fax
www.apd.com

ALDI Inc.
Tully Division
300 State Route 281
Tully, NY 13155-0584
(315) 656-2425
(315) 656-2426 fax

ALDI - Rochester, NY
NW Winton and Blossom
City of Rochester
Monroe County, NY

Project Name & Location:

DETAIL PLAN	
Drawing Name:	Project No.
Date: 11/18/14	13-0112
Type:	
Drawn By: SGC	C 7
Scale: 1"=30'	Drawing No.